

BASEMENT PLAN

**ASOOSOCIATES**  
 Soos & Associates, Inc.  
 Architecture  
 105 Schelster Road Lincolnshire Illinois 60069  
 phone: 847 821 7667 fax: 847 821 8570

**BASEMENT PLAN**

**BEVERLY FIRE STATION**


PROJECT NUMBER: 12SA106

DATE: 12-07-20

SCALE: NTS

DRAWN BY: JI

SHEET NUMBER: **FPBA**

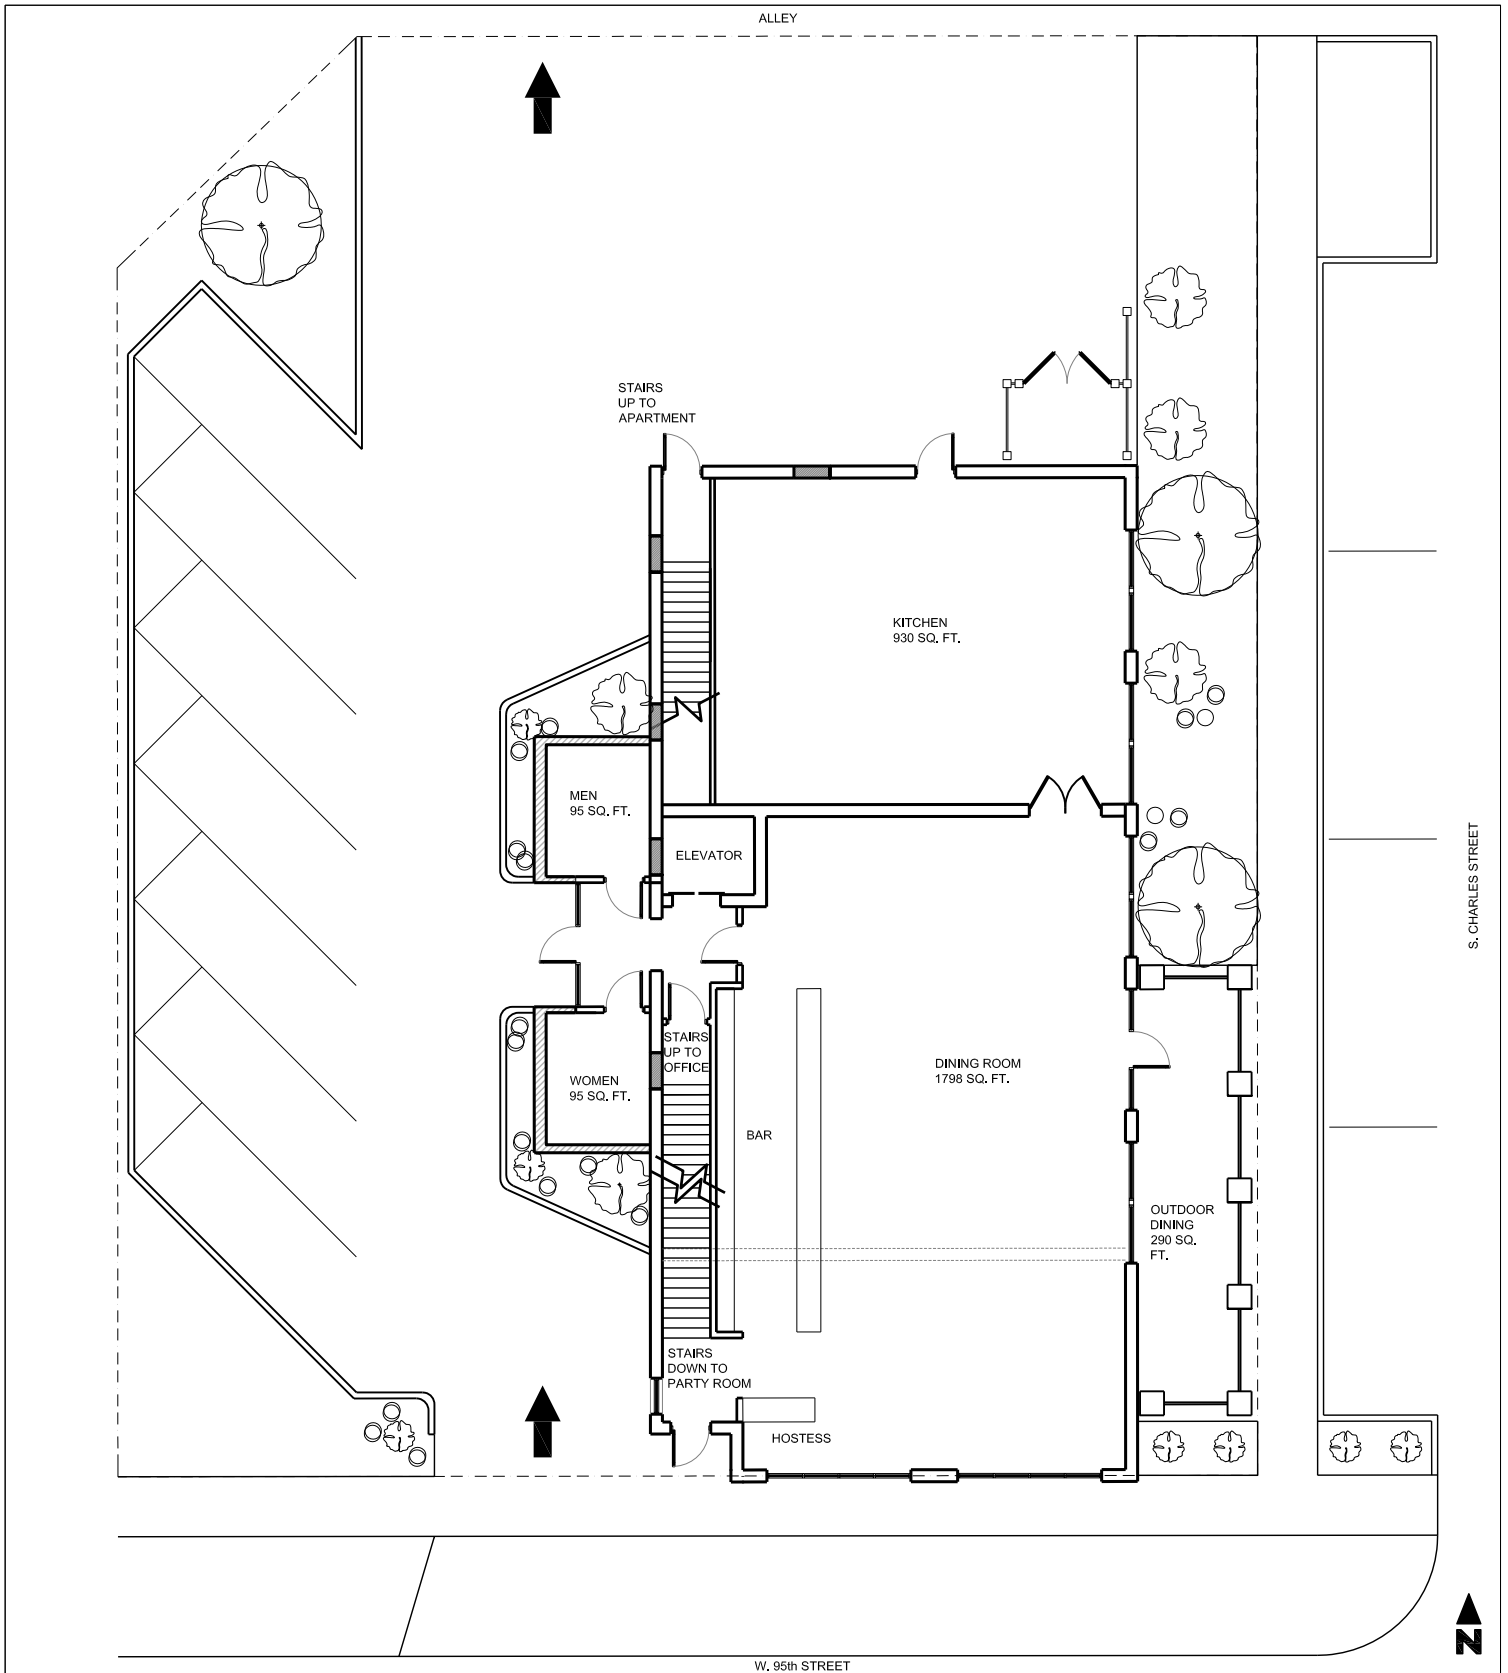

**ASOOSOCIATES**

Soos & Associates, Inc.  
Architecture

105 Schelter Road Lincolnshire Illinois 60069  
phone: 847 821 7667 fax: 847 821 8570

**1st FLOOR PLAN/  
SITE PLAN**

**BEVERLY FIRE STATION**


PROJECT NUMBER: 12SA106

DATE: 12-07-27

SCALE: NTS

DRAWN BY: JI

SHEET NUMBER: **FP1A**

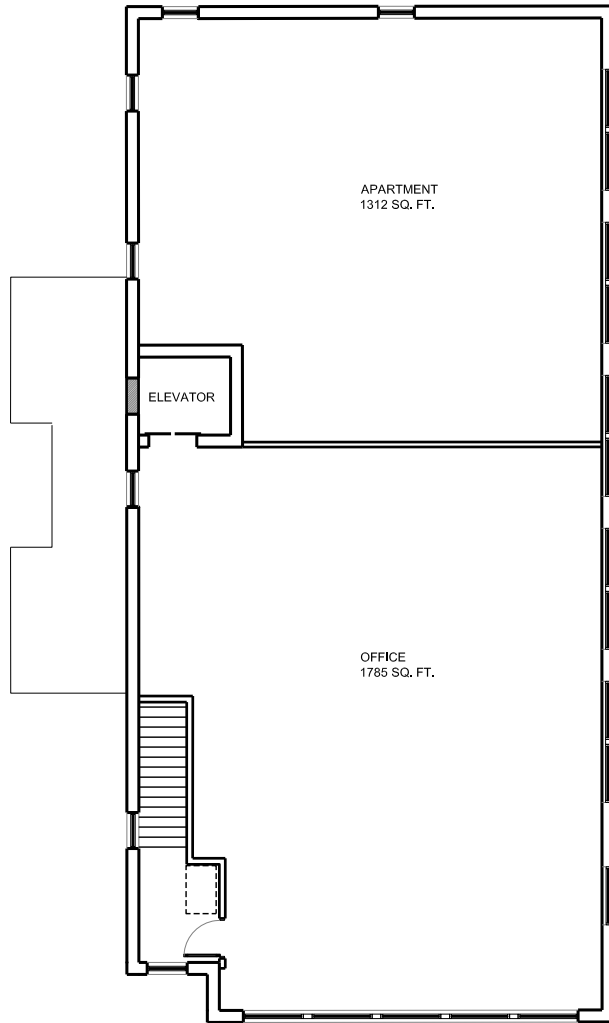

APARTMENT  
1312 SQ. FT.

ELEVATOR

OFFICE  
1785 SQ. FT.

**ASOOSOCIATES**

Soos & Associates, Inc.  
Architecture

105 Schelster Road Lincolnshire Illinois 60069  
phone: 847 821 7667 fax: 847 821 8570

## 2 ND FLOOR PLAN

BEVERLY FIRE STATION

PROJECT NUMBER: 12SA106

DATE: 12-07-20

SCALE: NTS

DRAWN BY: JI

SHEET NUMBER: **FP2A**